


KEY


- Existing services to remain
- Traditional Painted Cast Iron Radiator
 - Modern radiator
 - Heating Pipe
 - Pendant Light
 - Spot Light
- New services as proposed
- New Radiator
 - New surface mounted heating pipes
 - LED strip lighting
 - New recessed spot light
 - Pendant light in new location
 - New Spot Light

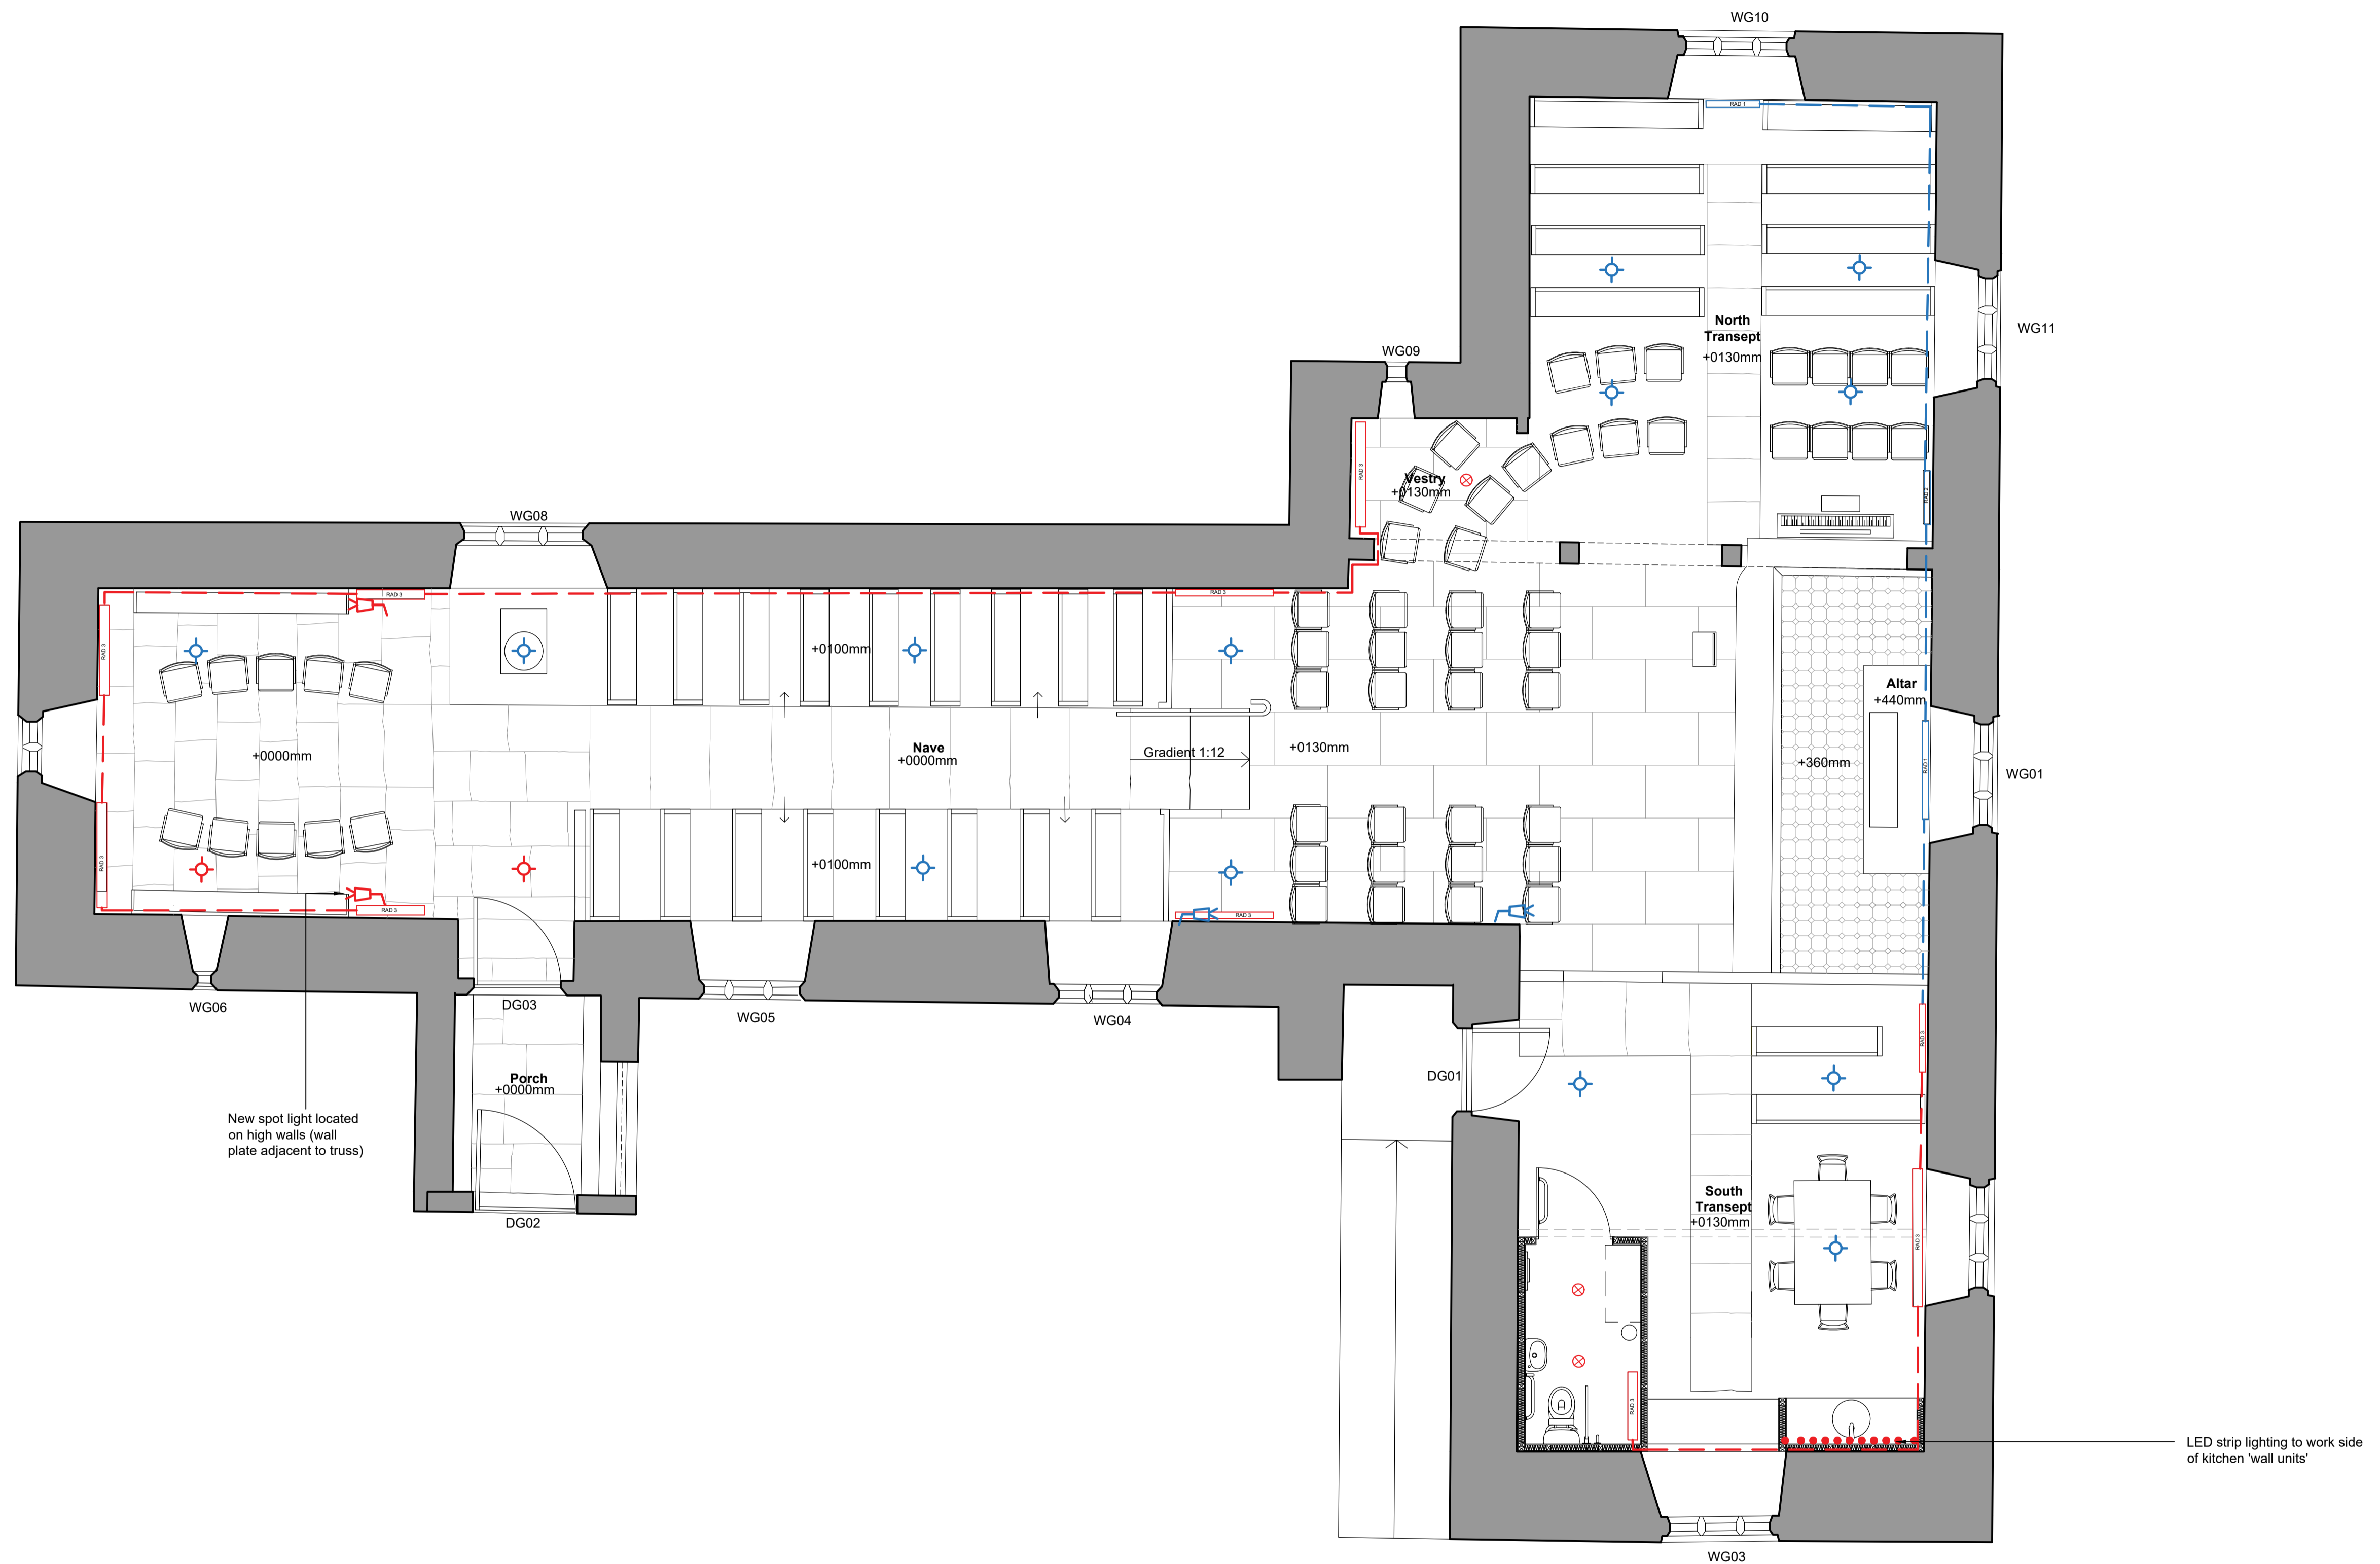

New spot light located on high walls (wall plate adjacent to truss)

LED strip lighting to work side of kitchen 'wall units'

M&E Ground Floor Plan as Proposed
Scale 1:50 @ A1

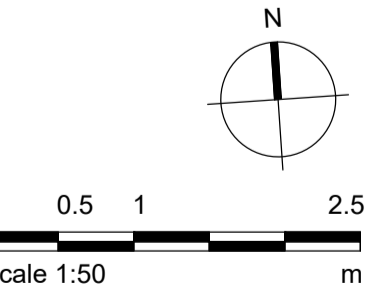

Notes

- Any dwg format drawing is to be read in conjunction with and at the scale of the accompanying pdf.
- Where colours other than black or grey are used, the drawing must be plotted in colour.
- For status 'C' (Construction) drawings all dimensions are to be checked on site by the contractor, scaling is for Local Authority purposes only.
- Unless otherwise indicated, all dimensions are in millimeters.
- All information on this drawing is to be read in conjunction with the relevant Donald Insall Associates specification and trade contractors' drawings and information by specialists.
- In the event of any discrepancy, please contact us immediately.
- This drawing may contain survey information by others and is to be used solely for the purposes for which it was issued.
- These are uncontrolled documents issued for information purposes only. If you have any queries regarding the drawings, please contact DIA immediately.
- Please note DIA cannot be held responsible for any errors arising from changes made to an uncontrolled dwg file.

Rev	Date	Dwn	Auth	Revision

Rev	Date	Dwn	Auth	Revision
1	17-03-22	ATB	EXJ	Issue for Faulty Consent
0	16-03-22	ATB	EXJ	For Initial use

Donald Insall Associates
Chartered Architects and Historic Building Consultants

Y Beows, Pool Lane
Conwy LL32 8PZ
(+44) 01492 592 378
conwy@insall-architects.co.uk

St. Benedict's Church, Gyffin

Project	BRO.CEL.04	No	2201
Scale (A1)	1:50	Status	P
		Revision	1

M&E Ground Floor Plan as Proposed